

TENNESSEE MODEL 737


1,920 SQUARE FEET
ACTUAL SIZE - 26'8" X 72'0"
TRANSPORTATION SIZE - 28 X 76
▲ LABEL LOCATION
NOTE: WALL HEIGHT - 8'



- LEGEND**
- L-101 - LITERATURE PLAN
 - AP-101 - FLOOR PLAN
 - EP-101 - ELECTRICAL PLAN
 - EV-101 - ELEVATIONS
 - A-103 - TYPICAL CROSS SECTION OFF-FRAME
 - A-104 - TYPICAL CROSS SECTION ON-FRAME
 - CB-101 - CABINET LAYOUT
 - F-202 - TYPICAL OFF-FRAME FOUNDATION - 100 MPH WIND (TYP)
 - F-301 - PERIMETER FOUNDATION
 - F-401 - FOUNDATION PLAN - 100 MPH WIND (TYP.)
 - P-101 - DRAIN LINE PLAN
 - WP-101 - WATER SCHEMATIC

BUILDING CODES:
2003 IRC
2003 NEC
2003 NEC
SAFETY GLAZING MATERIALS, TN CODE ANN.,
TITLE 68, CHAPTER 120, PART 3, WHERE APPLICABLE
OCCUPANCY:
RESIDENTIAL - R3
CONSTRUCTION TYPE:
WB - UNPROTECTED
INSULATION:
ROOF R-30 OR R-38
WALL R-13 OR R-19
FLOOR R-19 OR R-14
FURNACE REQUIRED - 12 KW,
BUILDING IS UNSPRINKLERED

DESIGN LOADS:
LIVE ROOF LOAD - 20 PSF
DEAD ROOF LOAD - 15 PSF
WIND LOAD - 100 MPH
90 MPH EXPOSURE "C"
SEISMIC DESIGN: C-STYD, D1 & D2-OPT
LIVE FLOOR LOAD - 40 PSF
DEAD FLOOR LOAD - 10 PSF
NUMBER OF FLOORS: 1
FLOOR AREA: 1,920 SQ. FT.

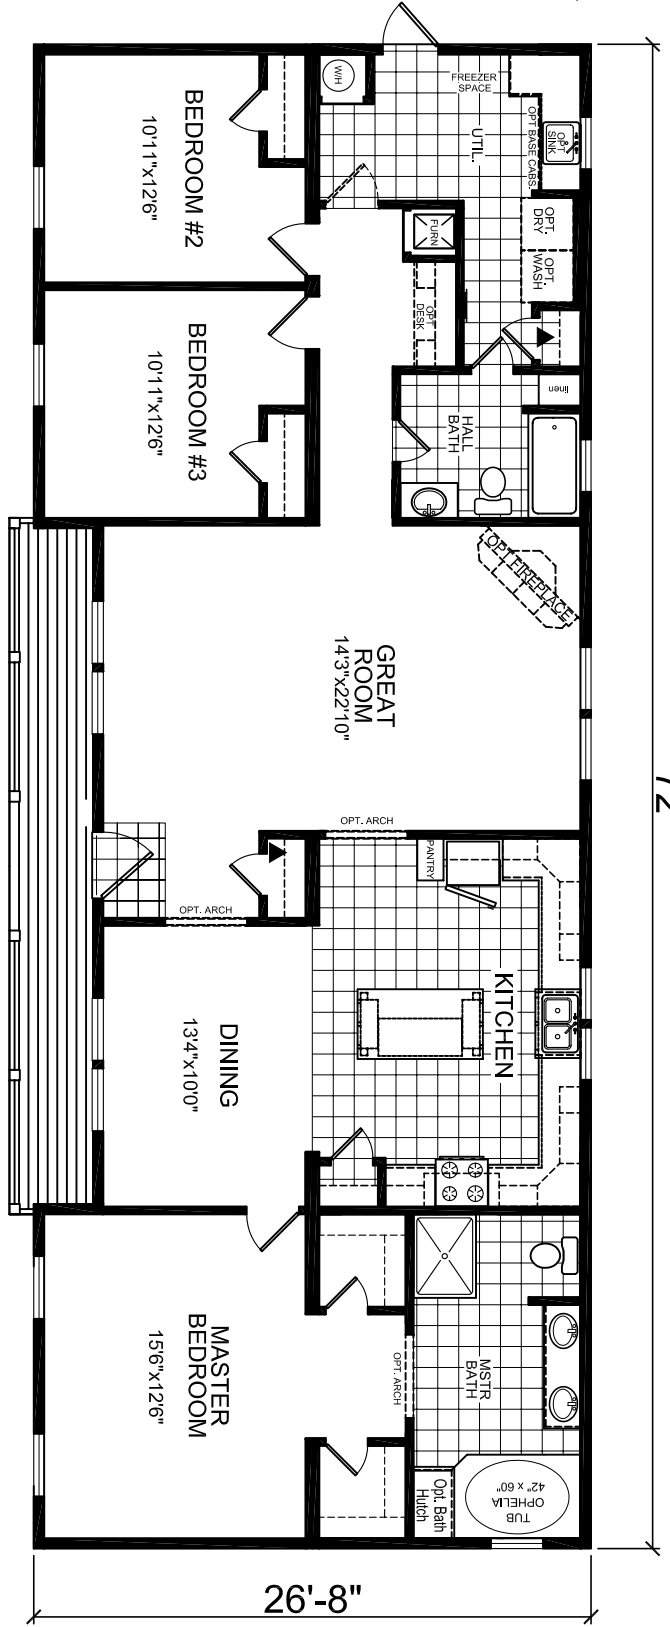

TENNESSEE PLAN # AH1-10



Champion
HOMES OF TENNESSEE

560 ATLANTIC AVE. HENRY, TN 38231

DAPIA SEAL

MODIFICATIONS

MODEL: 21-737
3 BEDROOM, 2 BATH
TITLE: LITERATURE PLAN
DRAWN BY: S. BROOKS
DATE: 2007

SHEET: L-101

PROPRIETARY AND CONFIDENTIAL
THESE DRAWINGS AND SPECIFICATIONS ARE ORIGINAL
PROPRIETARY AND CONFIDENTIAL MATERIALS OF CHAMPION.
COPYRIGHT © 1976-2006 BY CHAMPION