





Champion HOMES OF TENNESSEE

560 ATLANTIC AVE. HENRY, TN 38231

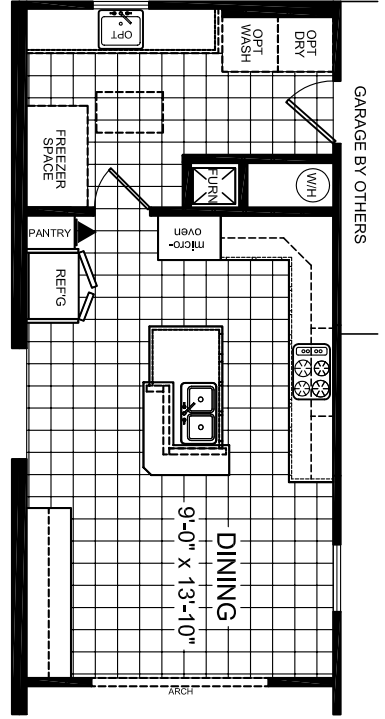

**MISSISSIPPI
MODEL 784**

1,624 HEATED AREA
ACTUAL SIZE - 29'0" X 62'0"
TRANSPORTATION SIZE - 31 X 66
▲ LABEL LOCATION

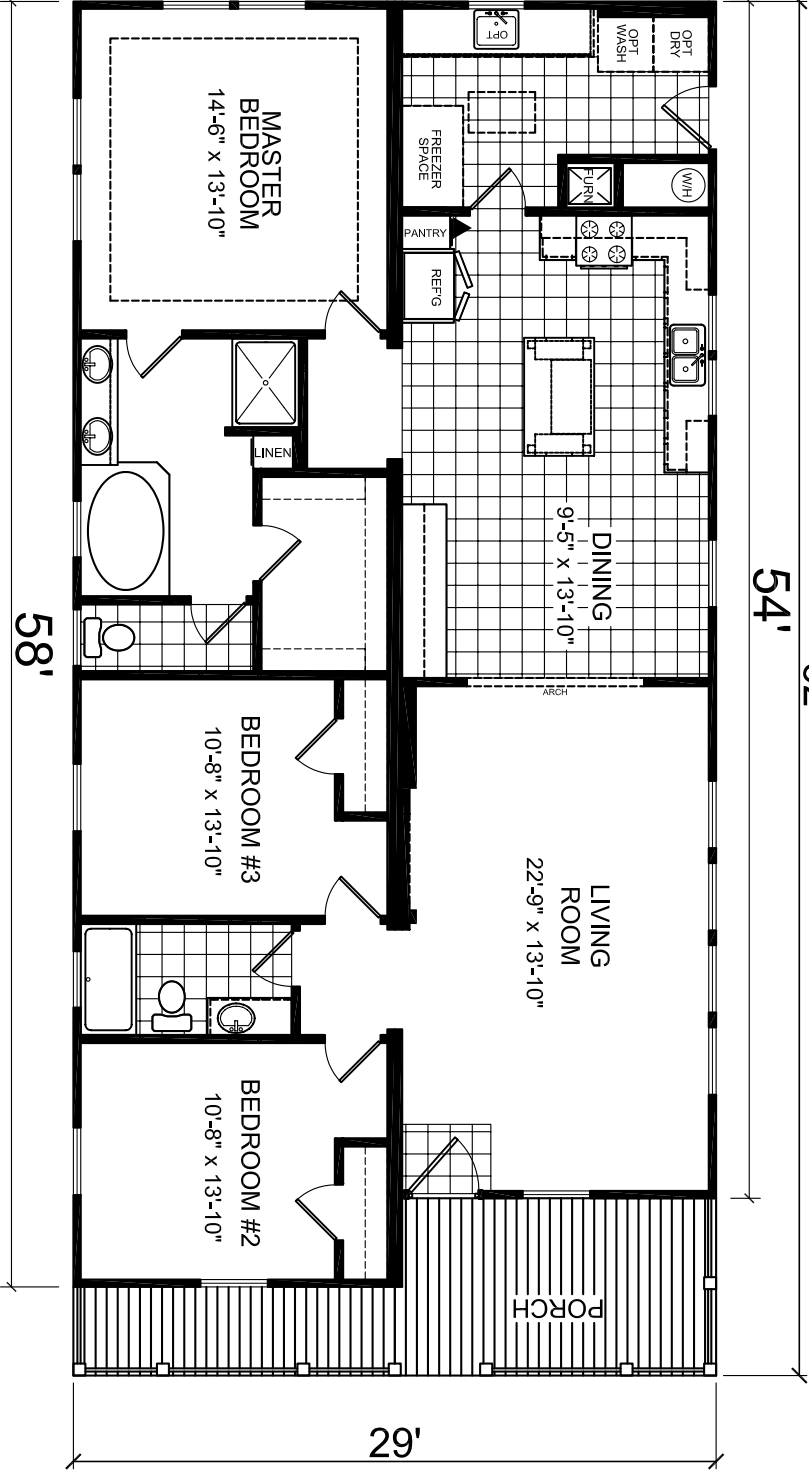

BUILDING CODES:
2003 IRC
2000 IECC
2005 NEC
OCCUPANCY: RESIDENTIAL - R3
CONSTRUCTION TYPE: VB - UNPROTECTED INSULATION:
ROOF R-30 OR R-38
WALL R-13 OR R-19
FLOOR R-19 OR R-14
FURNACE REQUIRED - 12 KW.
LPG / NATURAL GAS
BUILDING IS UNSPRINKLERED

DESIGN LOADS:
LIVE ROOF LOAD - 20 PSF
DEAD ROOF LOAD - 15 PSF
WIND LOAD - 110 & 140 MPH EXPOSURE "C"
SEISMIC DESIGN: C
LIVE FLOOR LOAD - 40 PSF
DEAD FLOOR LOAD - 10 PSF
NUMBER OF FLOORS: 1
FLOOR AREA: 1,682 SQ. FT.

NOTE: MODEL MAYBE FLIPPED END TO END

LEGEND
L-101 - LITERATURE PLAN
AP-101 - FLOOR PLAN
EV-101 - ELEVATIONS
K-101 - CABINET LAYOUT
F-202 - TYPICAL OFF-FRAME FOUNDATION
P-101 - DRAIN LINE PLAN
W-101 - WATER SCHEMATIC
G-101 - TYPICAL GAS RISER DIAGRAM
EP-101 - ELECTRICAL PLAN
MD-101 - OPTIONAL FIREPLACE

MODIFICATIONS

MODEL:	21-784	SHEET:	L-101
TITLE:	LITERATURE PLAN		
DRAWN BY:	DIV-21	DATE:	2006
SCALE:	1/8" = 1'-0"		